


DWG No.	SKY-WRP-P-100
Revision	2
Description	.
Drawn	G Schurr
Date	26/02/2020
Template	v 0.1

Process Flow Diagram
KYNETON WATER RECLAMATION PLANT
 PLANT MAXIMUM DESIGN CAPACITY 2.7ML/day (BNR) + 0.48ML/day (Trade Waste)



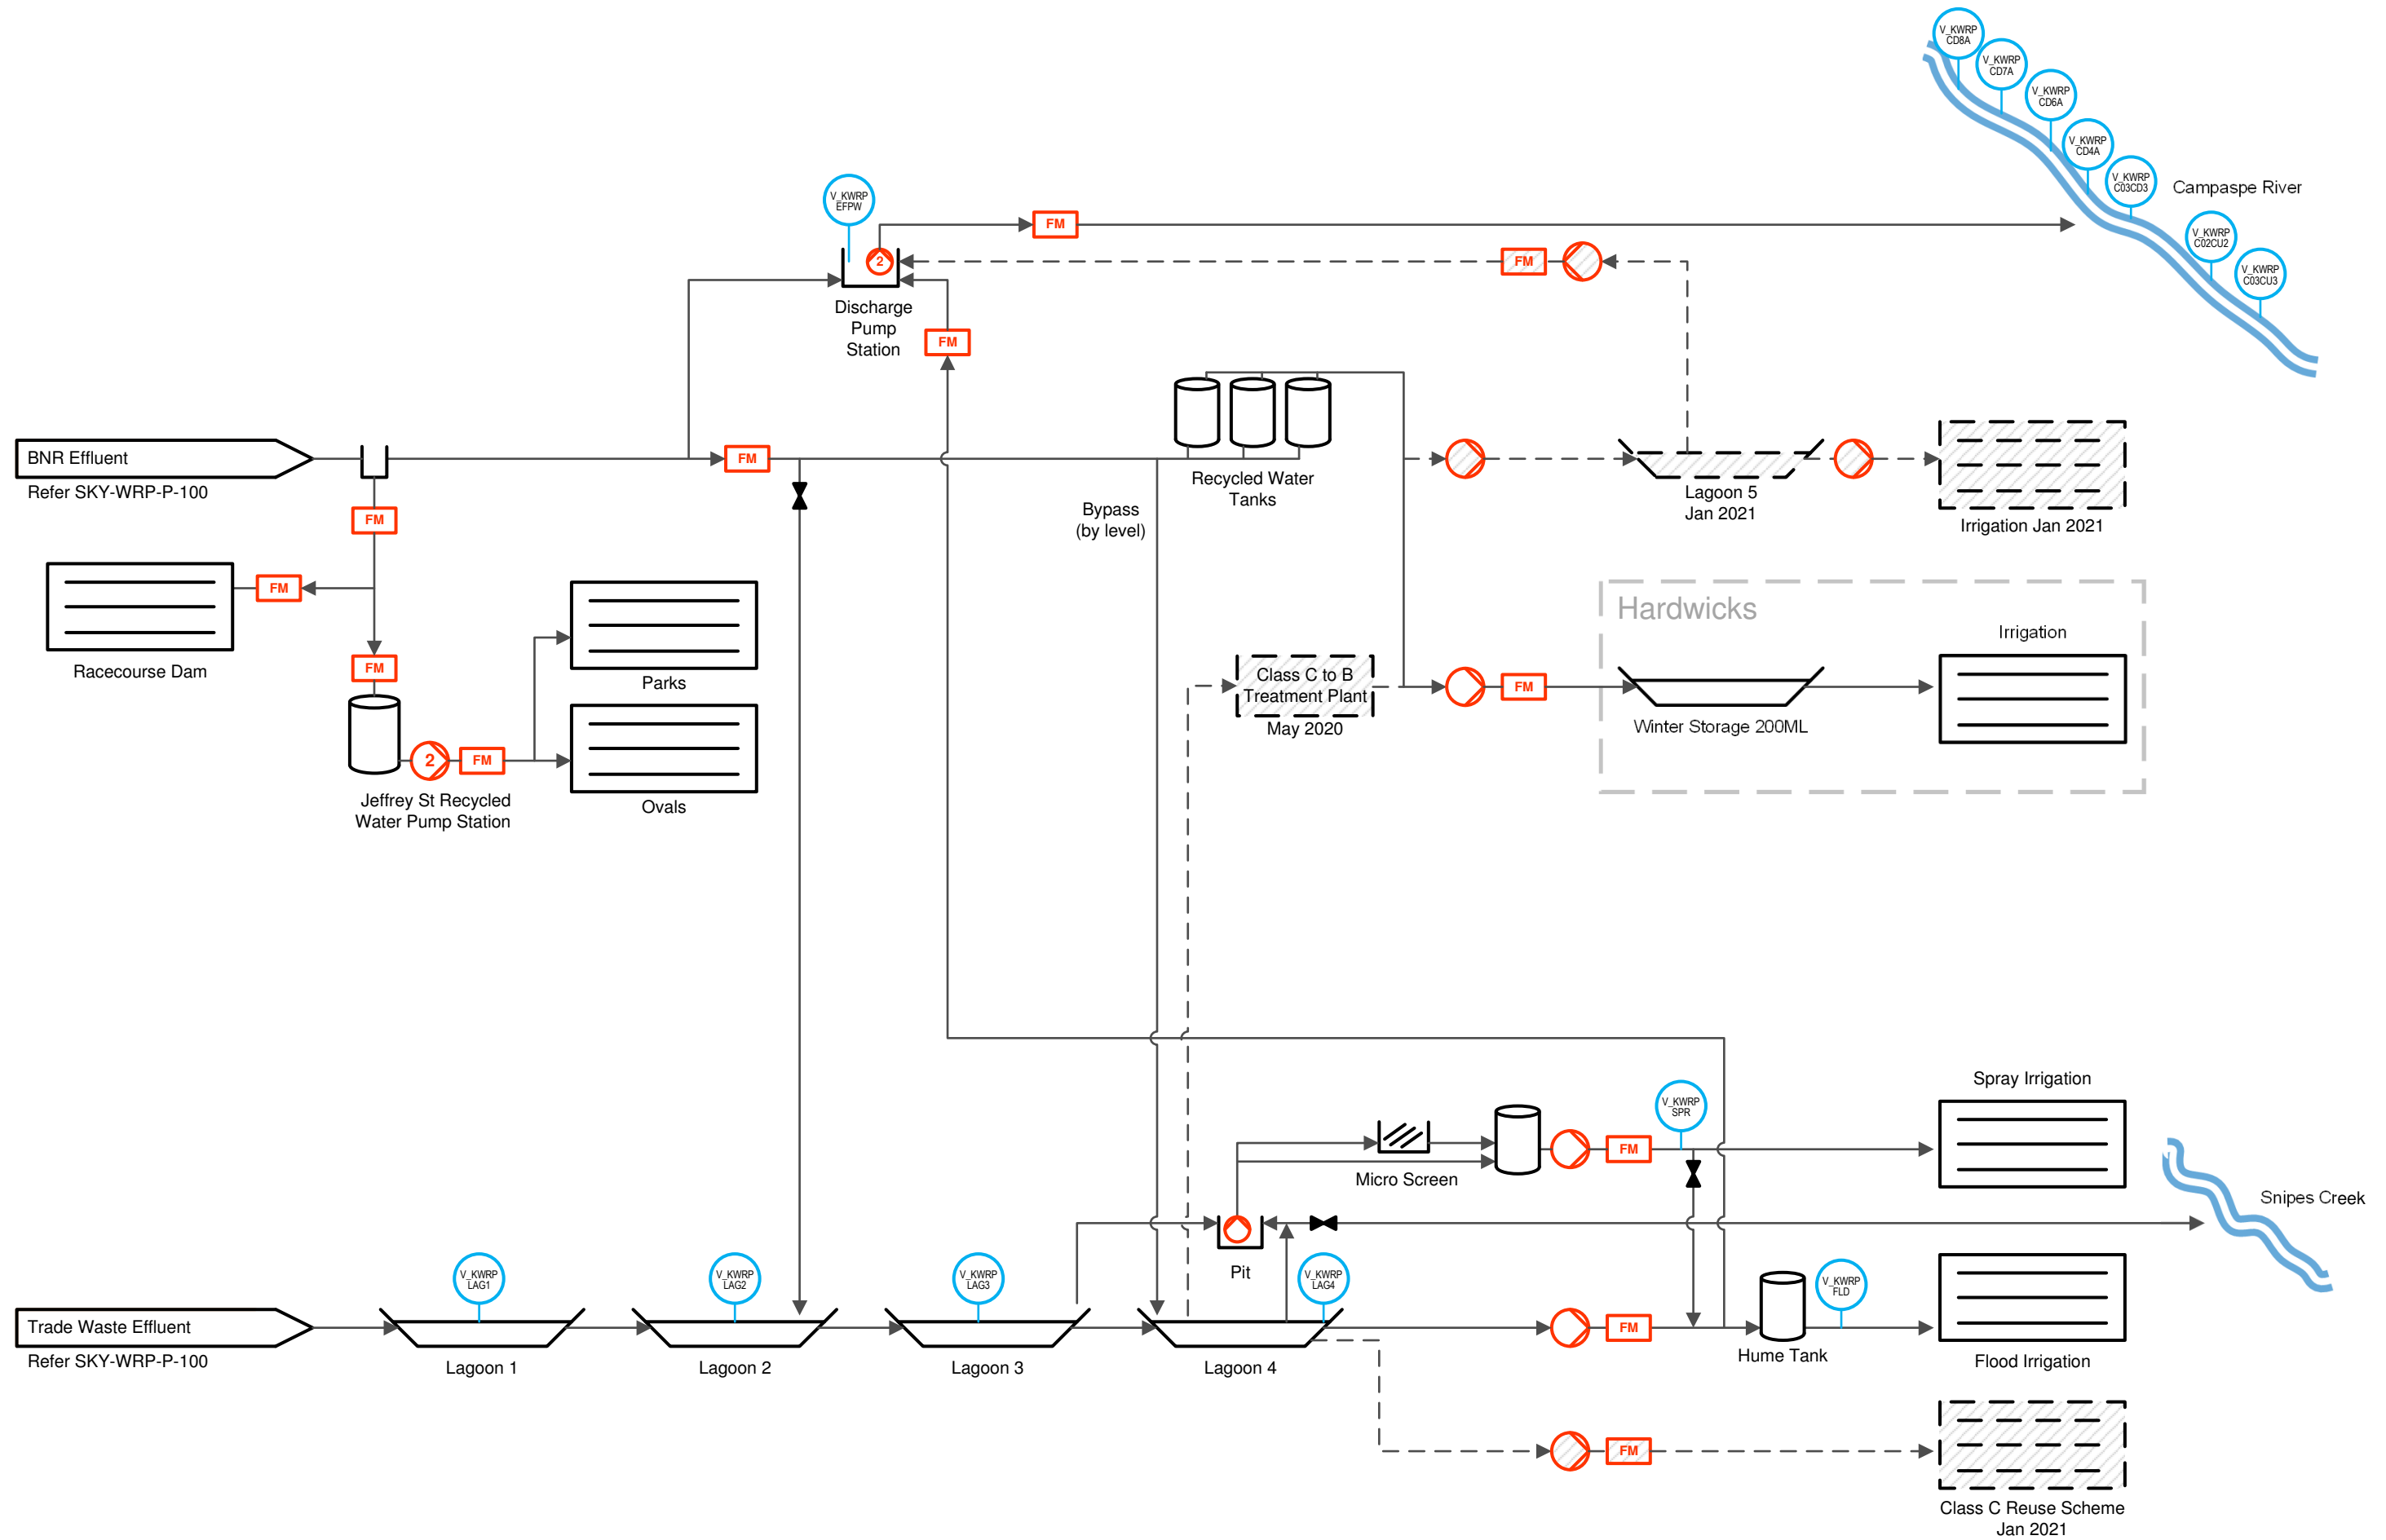

DWG No.	SKY-WRP-P-101
Revision	2
Description	
Drawn	G Schurr
Date	26/02/2020
Template	v 0.1

Process Flow Diagram
KYNETON WATER RECLAMATION PLANT
 PLANT MAXIMUM DESIGN CAPACITY 2.7ML/day (BNR) + 0.48ML/day (Trade Waste)

